



Wilkins Residence Pool and Surrounds Master Plan

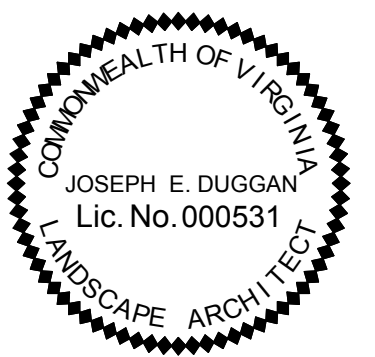

No.	Date	Revisions
Design Firm		
151 Windy Hill Lane, Winchester, VA 22602 (540)974-2475 www.jdugganandassociates.com		
Consultant		
Project Title		
Pool and Surrounds		
Drawing Title		
Planting and Lighting Plan		
Project Manager		
J Duggan RLA		
Drawn By	Scale	
TM/JD	As Shown	
Reviewed By	Drawing No.	
JD		
Date		
08-23-2015		
CAD File		
	5 of 5	Total Sheets

Lighting Legend

- Pathlight
- Uplight
- Steplight
- Wall light

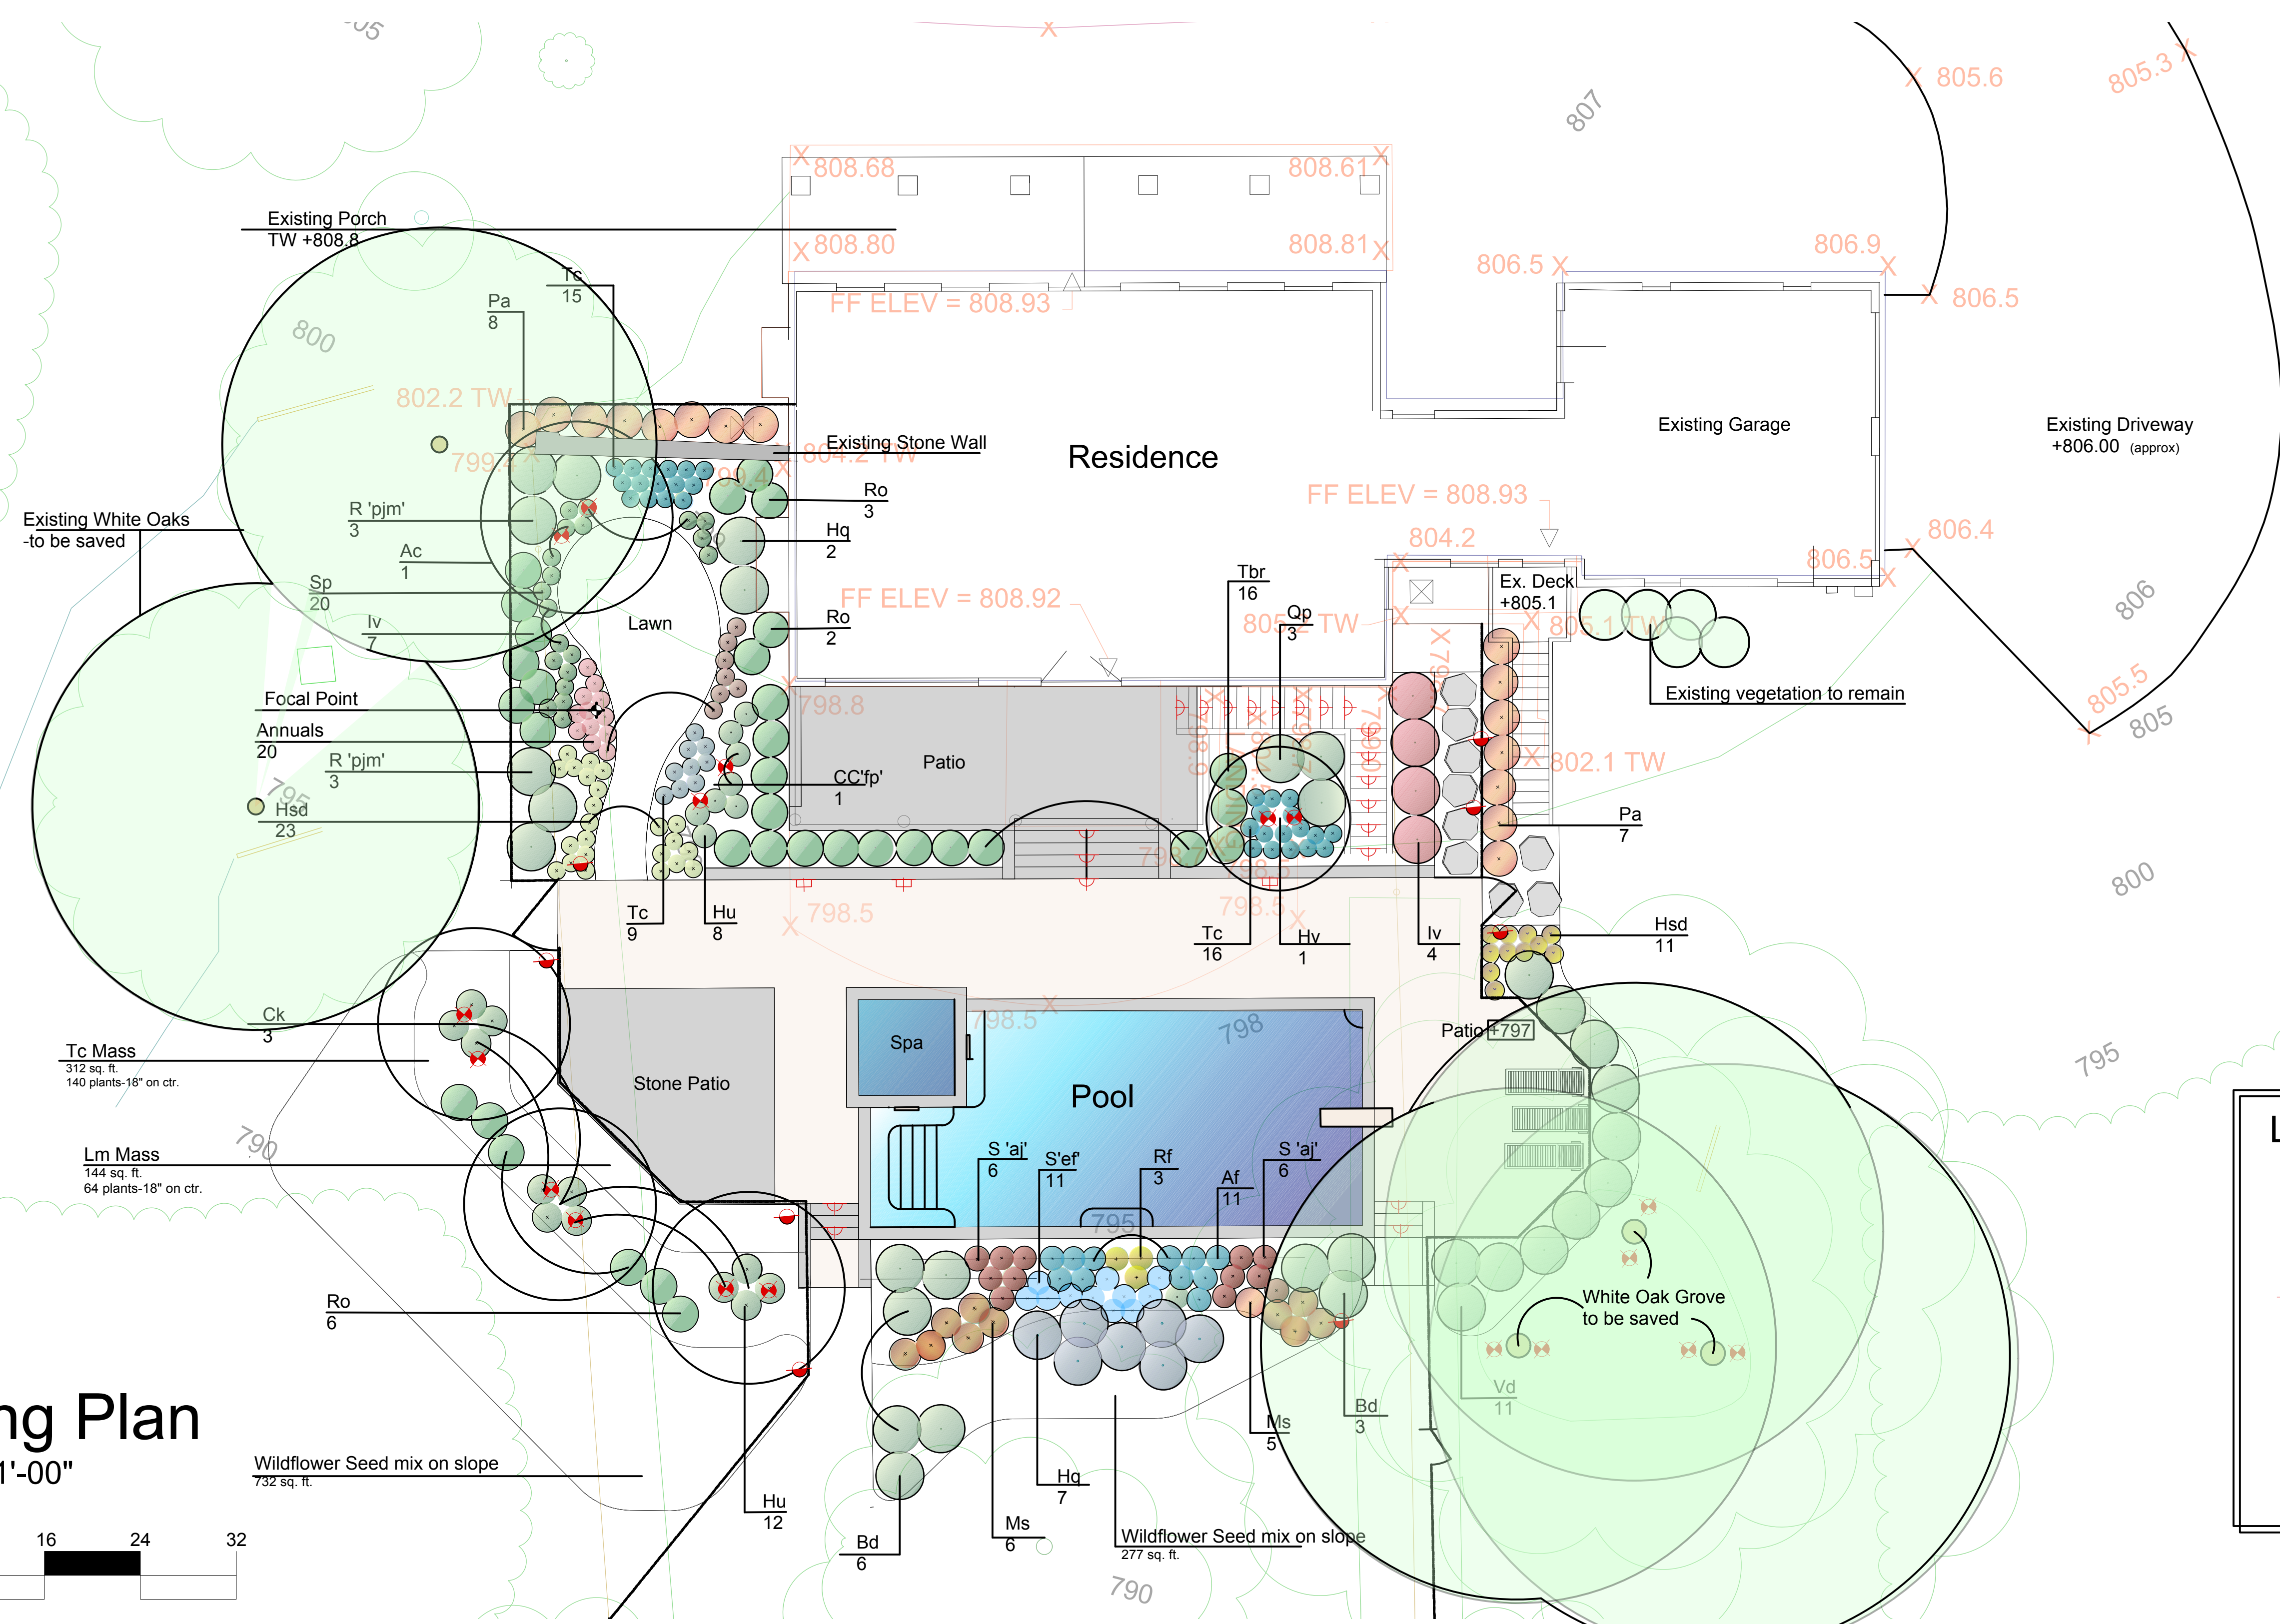

Planting Plan

scale 1/8" = 1'-00"

Plant List

Trees				
Abb	Botanic Name	Common Name	Type	Qty
Ac	Amelancier canadensis	Serviceberry	Ornamental	1
Cc 'fp'	Cercis canadensis 'Forest Pansy'	Forest Pansy Redbud	Ornamental	1
Ck	Cornus kousa	Kousa Dogwood	Ornamental	3
Hv	Hamamelis virginiana 'Arnolds Promise'	Arnold's Promise Witchhazel	Ornamental	1

Shrubs				
Abb	Botanic Name	Common Name	Type	Qty
Bd	Buddleia davidii	Butterfly bush	Ornamental	6
Hq	Hydrangea paniculata	Pee Gee Hydrangea	Ornamental	3
Hq	Hydrangea quercifolia	Oakleaf Hydrangea	Ornamental	9
Iv	Itea virginica 'Henry's Garnet'	Virginia Sweetspire	Ornamental	11
Ro	Rhododendron x obtusum	Kurume Azalea	Evergreen	9
R'pjm'	Rhododendron 'pjm'	PJM Rhododendron	Evergreen	3
Tb 'R'	Taxus baccata 'Repanders'	Weeping English Yew	Evergreen	16
Vd	Viburnum dilatatum	Linden Viburnum	Ornamental	11

Perennials, Groundcover					
Abb	Botanic Name	Common Name	Type	Qty	Spacing
Af	Aster frikati 'Monch'	Monch Aster	Perennial	11	24" on ctr.
Annuals	Assorted Annuals	Per season	Annual	24	18" on ctr.
Hsd	Hemerocallis 'Stella D'Oro'	Stella D'Oro Daylily	Perennial	34	18" on ctr.
Hu	Hosta undulata	Hosta	Perennial	20	18" on ctr.
Lm	Liriope muscari	Liriope	Groundcover	64	18" on ctr.
Ms	Miscanthus sinensis	Maidengrass	Ornamental grass	11	30" on ctr.
Pa	Pennisetum alopecuroides	Fountain grass	Ornamental grass	8	30" on ctr.
Rf	Rudbeckia fulgida 'goldsturm'	Goldsturm Black Eyed Susan	Perennial	3	18" on ctr.
S	Salvia 'East Friesland'	East Friesland Salvia	Perennial	11	24" on ctr.
S 'AJ'	Sedum 'Autumn Joy'	Autumn Joy Sedum	Perennial	12	18" on ctr.
Sp	Shade Perennials	Ferns, Dicentra, Astilbe, etc	Perennial	20	18" on ctr.
Tc	Tiarellia cordifolia	Foam flower	Groundcover	180	18" on ctr.

Note:
These are not construction documents-final layout and dimensioning of all proposed items to be finalized by contractor during bidding process. J. Duggan Associates is not responsible for problems arising from use of these documents for actual construction.